


Project Information:

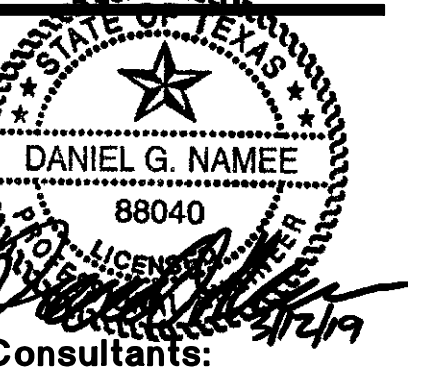

DG Engineering LLC
 6019 Cerritos Houston, TX 77035
 Ph) 713-729-6125 F) 713-729-6135
 TBE FIRM # 7689

SHOPS ON GOSLING
 RETAIL CENTER
 SHELL BUILDING DEVELOPMENT
 24309 GOSLING ROAD
 SPRING, TEXAS 77389

Sheet Title:

ELECTRICAL
 Plans

Issue:

CD/PERMIT


Issue Date:

10 DECEMBER 2018 - SD
 12 MARCH 2019 - CD/PERMIT


Revision Date:

Sheet:

E2.01

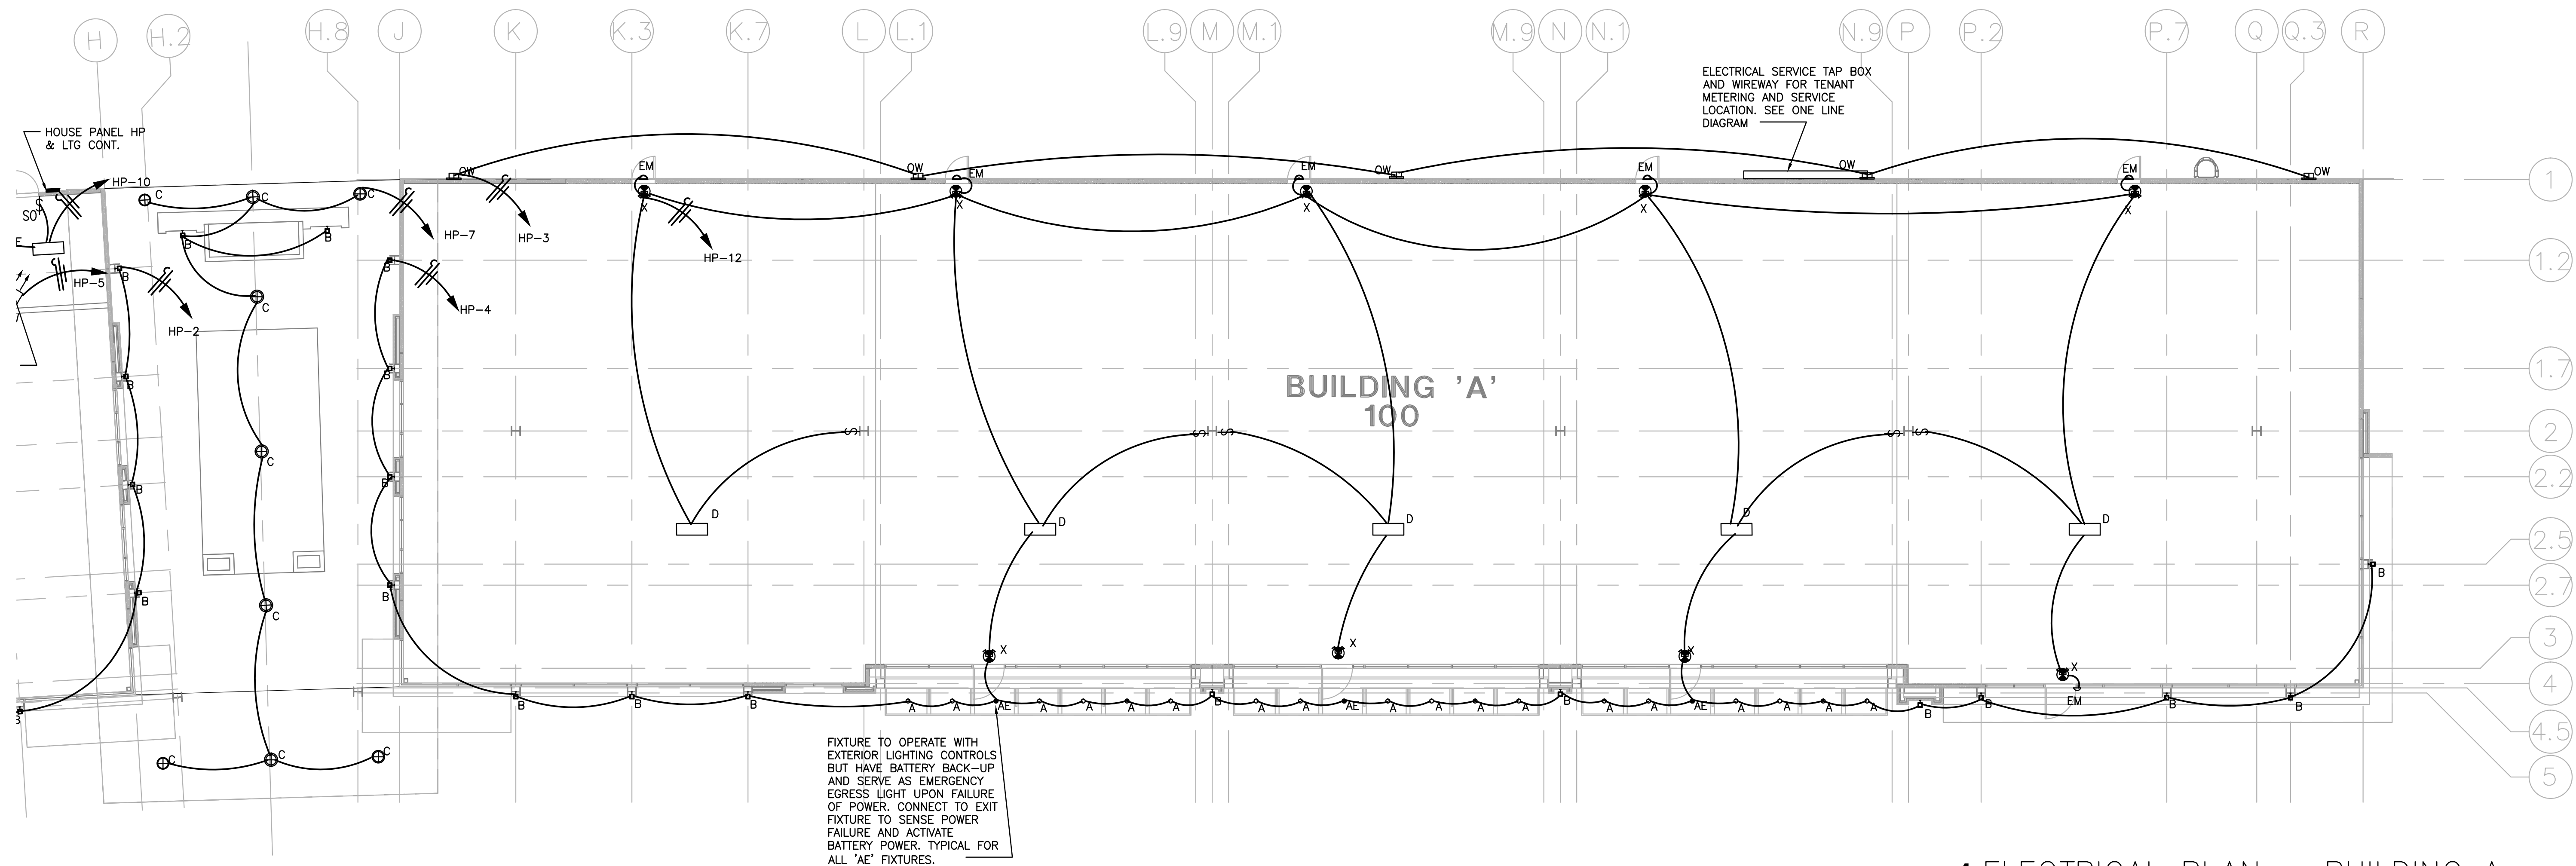

1 ELECTRICAL PLAN - BUILDING A
 3/32" = 1'-0"

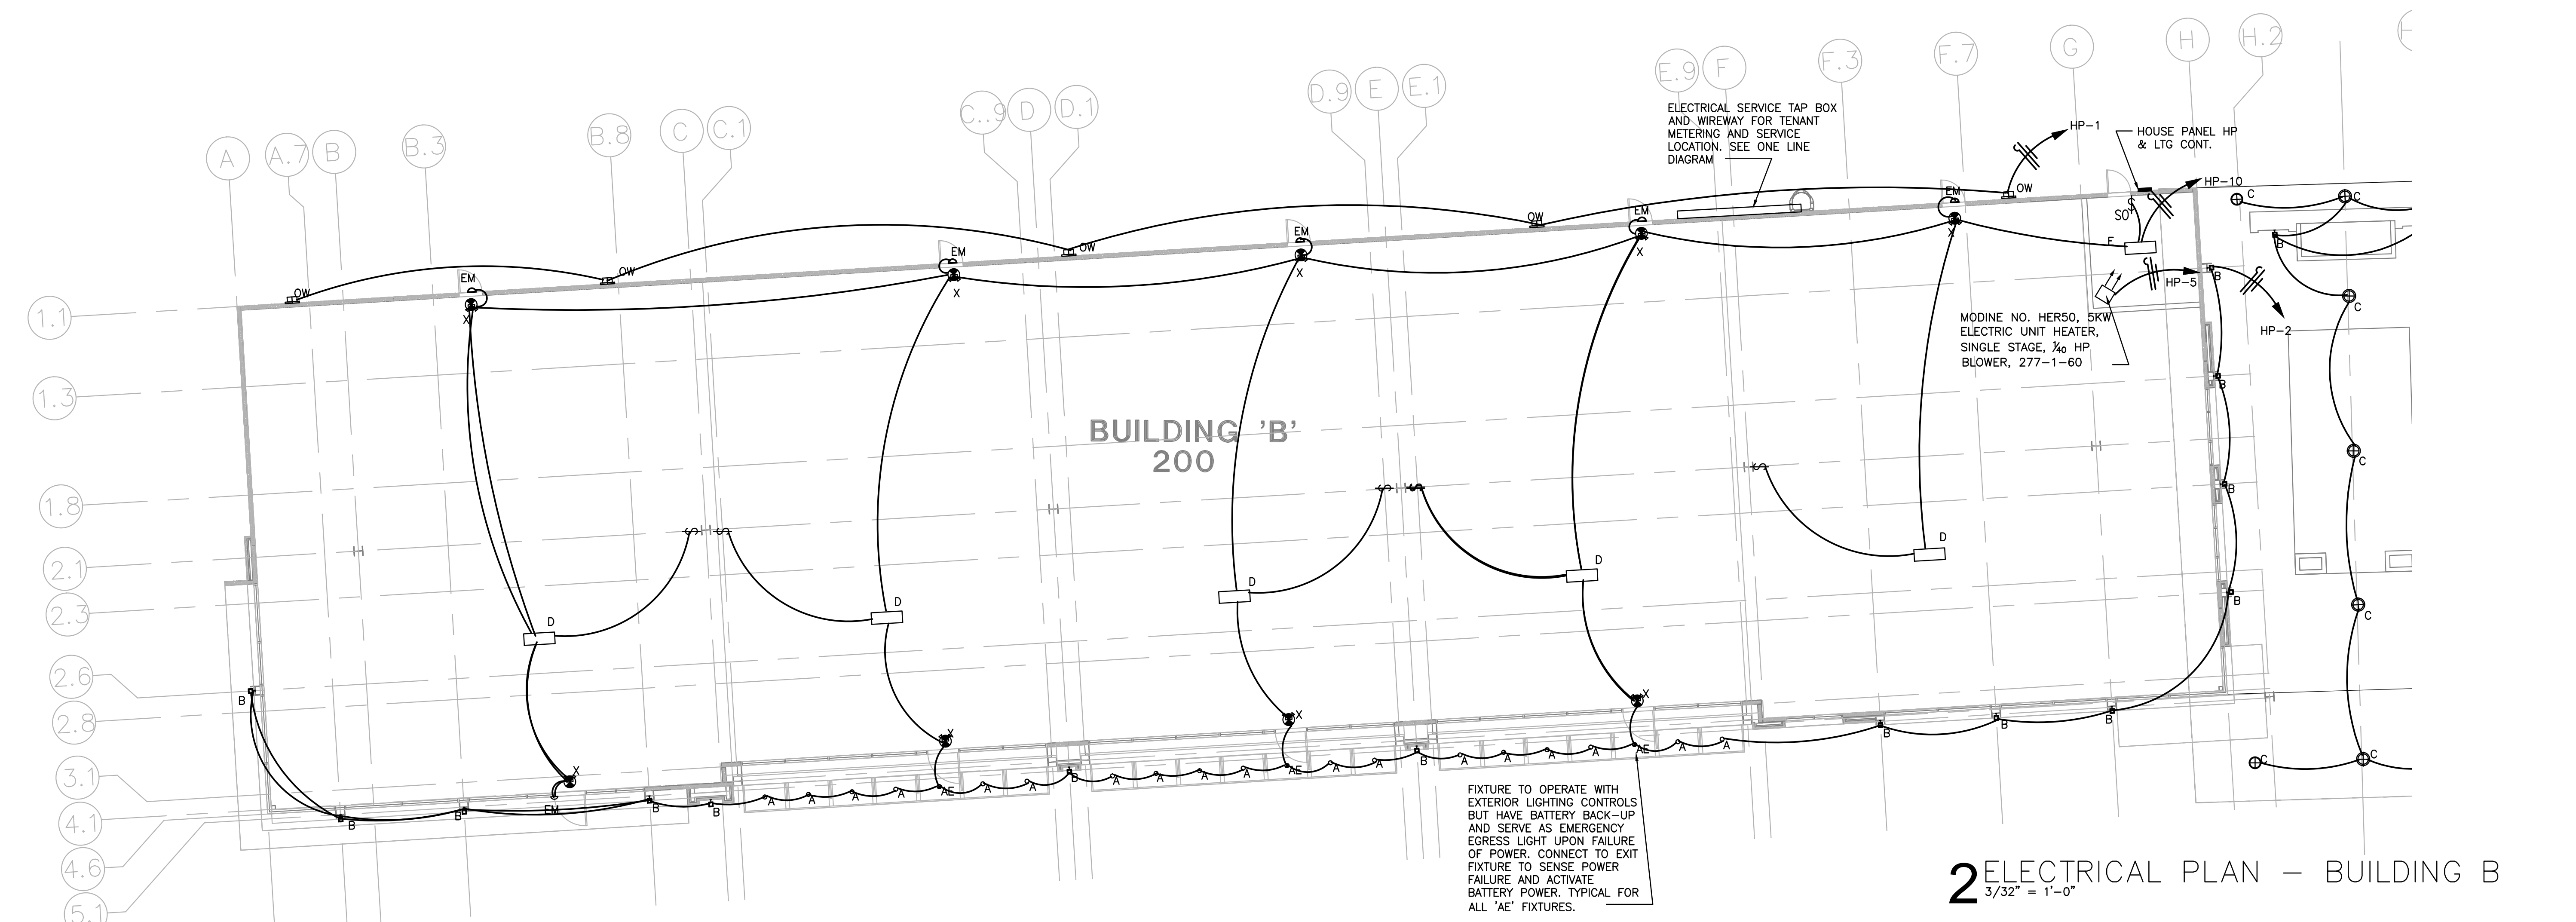

2 ELECTRICAL PLAN - BUILDING B
 3/32" = 1'-0"

COPYRIGHT © GOULAS + ASSOCIATES, INC. ALL DRAWINGS, SPECIFICATIONS AND DESIGNS APPEARING HEREIN CONSTITUTE THE ORIGINAL AND UNPUBLISHED WORK OF THE ARCHITECT, DESIGNER AND HIS/HER ASSOCIATES, AND THE SAME MAY NOT BE DUPLICATED, USED OR DISCLOSED WITHOUT THE EXPRESS WRITTEN CONSENT OF THE ARCHITECT/DESIGNER.